

A


B

C

D

E

F

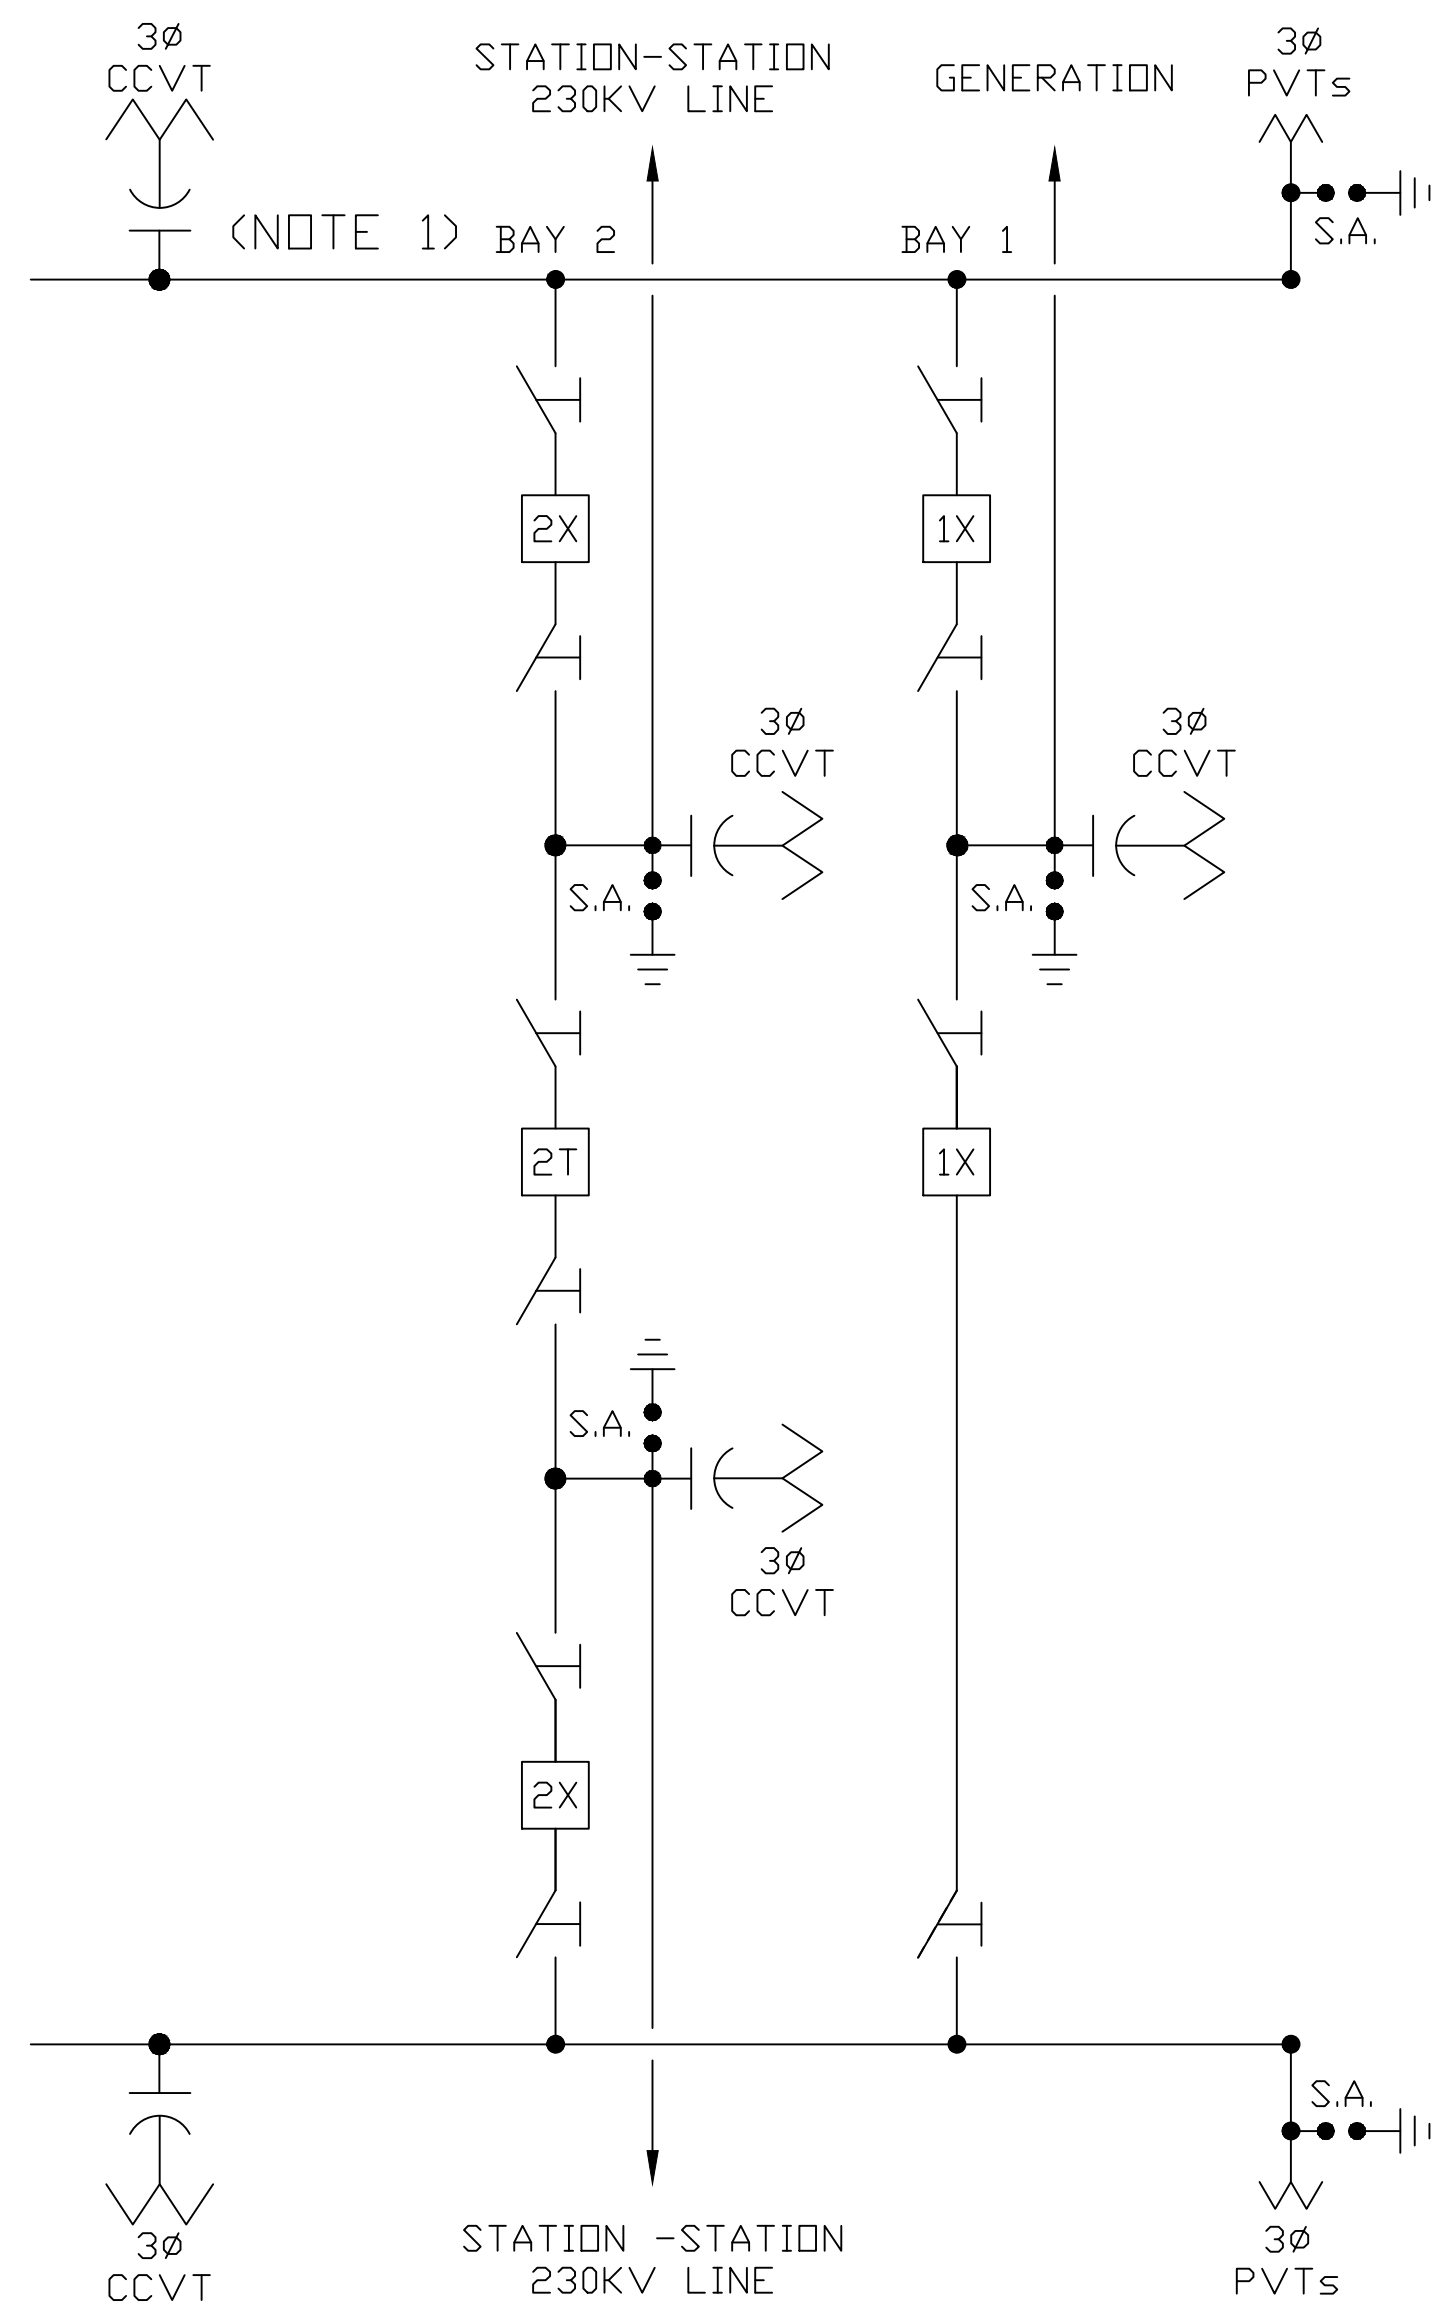

OF THE DRAWING.

 PPL ELECTRIC UTILITIES

ACCT.-		STANDARD 230KV IPP SUBSTATION		PPL ELECTRIC UTILITIES	
ECN #-				ONE LINE DIAGRAM	
SCALE-				PRIMARY DIAGRAM	
BY-					
REV'D-					
		APPROVED		DATE	
				PPL ELECTRIC UTILITIES	
AC		D		DRAWING NO.	
R. CAD ID		FORMAT		SHEET NO.	
		EU00507003		1	
		E		N	
		SORTS		SHARE	
ODE				THIS FORMAT CONTAINS REQUIRED METADATA ATTRIBUTES	

PPL ELECTRIC UTILITIES
FORM 4877 (02/16)
