


THIS DRAWING IS THE PROPERTY OF PPL ELECTRIC UTILITIES AND CONTAINS PROPRIETARY AND CONFIDENTIAL INFORMATION WHICH MUST NOT BE REPRODUCED OR TRANSMITTED IN ANY FORM OR BY ANY MEANS WITHOUT WRITTEN AUTHORIZATION FROM PPL ELECTRIC UTILITIES.

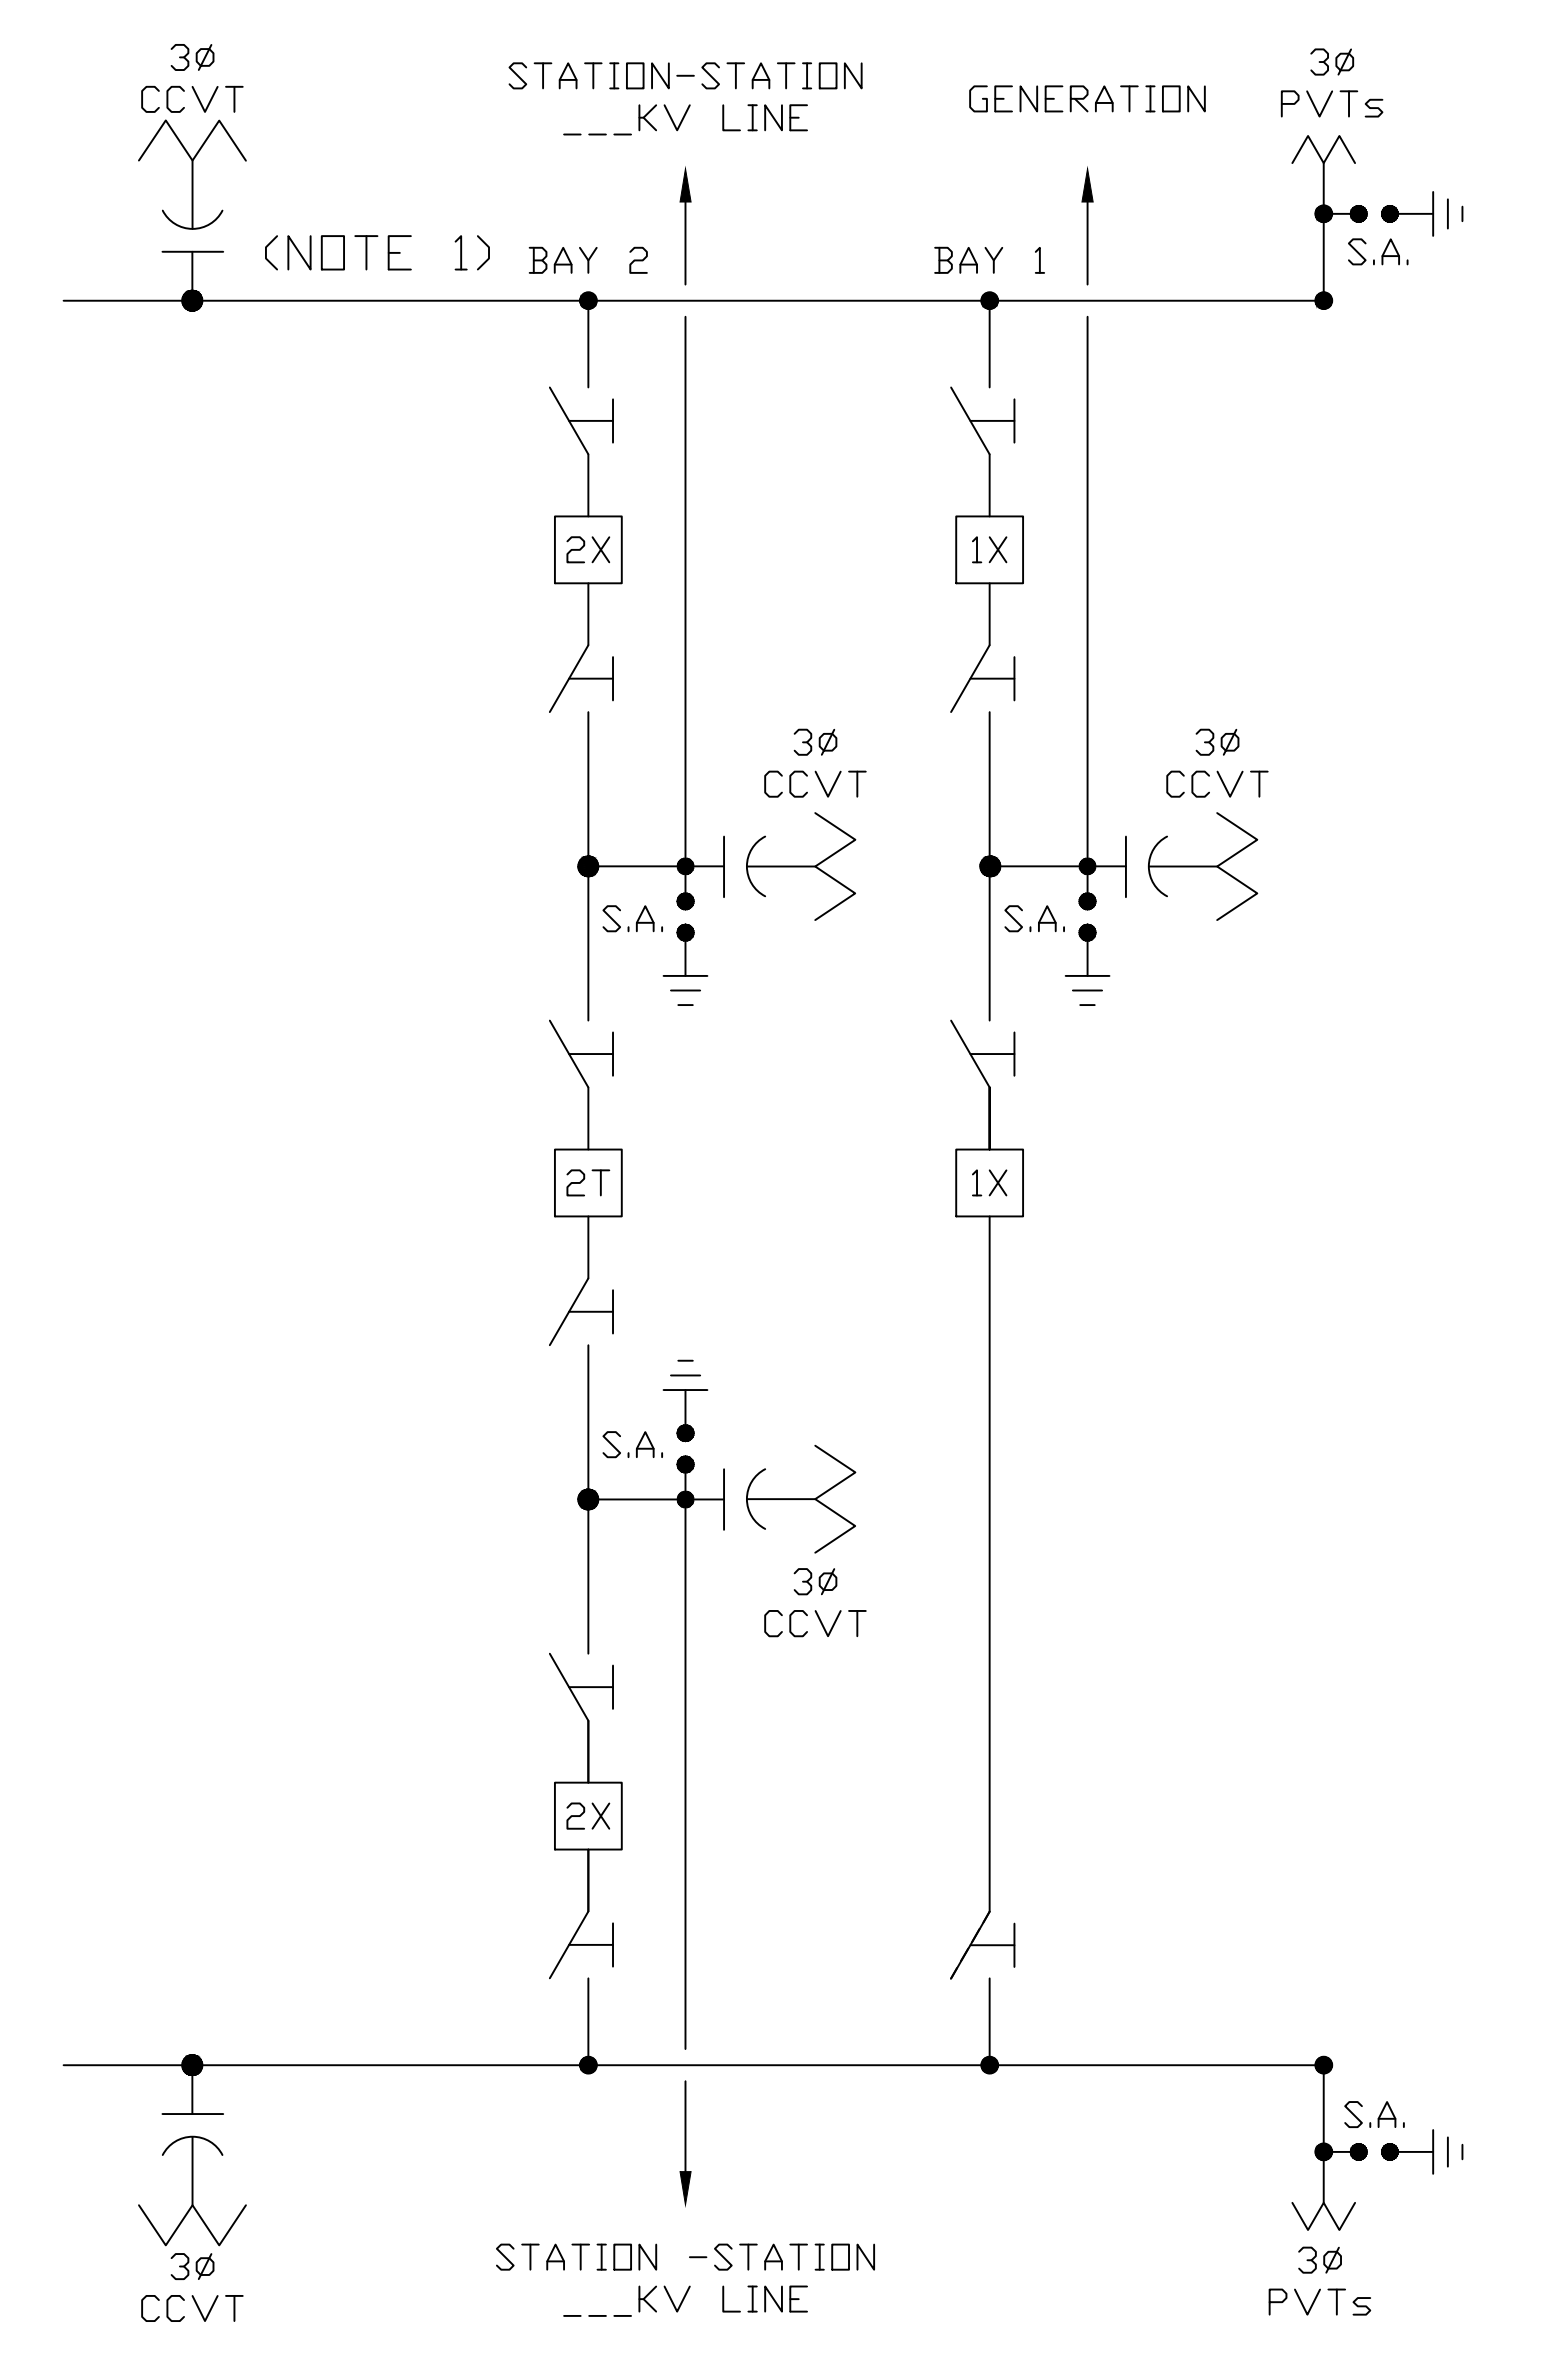

NOTES:
 1. BUS DESIGNATION/LAYOUT SHOULD BE THAT NORTH OR EAST BUS IS LOCATED ON THE TOP OF THE DRAWING.



ACCT.-	STANDARD 500KV AND 230KV IPP SUBSTATION ONE LINE DIAGRAM PRIMARY DIAGRAM
ECN #	
SCALE-	
BY-	
REV'D-	

APPROVED		DATE	PPL ELECTRIC UTILITIES	
AC	D	DRAWING NO.	SHEET NO.	REVISION
		EU00543369	1	0

REFERENCE TITLE	NUMBER	REFERENCE TITLE	NUMBER	NO.	DATE	ACCT.	ECN/FCN	REVISION	BY	REV'D	APPR.	CAD ID	FORMAT